



GENERAL NOTES:

1. This drawing is to be read in conjunction with all other relevant Engineering and Architect's details.
2. The design details presented must be reviewed in conjunction with the wider site information and site constraints which may not be evident on drawing and must be requested if not already provided. This includes, but not limited to, ground conditions (geotechnical and geo-environmental), groundwater levels, buried services, remnant obstructions, ecology, tree protection and topography. The Engineer shall be notified immediately, in writing, should any errors or discrepancies be found prior to the commencement or continuation of any works.
3. All work is to be carried out in accordance with current British Standards, Building Regulations and NHBC Standards. It is the responsibility of the Contractor to execute the works at all times in strict accordance with the requirements of the Health and Safety at Work Act 1974, and the C.D.M. Regulations 2015. The Contractor will be deemed to have allowed for full compliance, including full liaison with the CDM Co-ordinator, within his rates.
4. Any existing details which are shown on this drawing are for guidance only and are to be checked on site by the contractor. Any variations are to be recorded and reported to the engineer immediately.
5. Before work commences contractor should consult the engineer and the SI report regarding any contamination issues. All necessary Health and Safety measures to be taken

PRELIMINARY SCHEME


For comment and review only.
Design is based upon information available at the time.
Design is subject to full review as additional information becomes available.
Design is subject to full review upon receipt of comments from:
• Development Control
• LA Planning Authority
• Environment Agency
• LA Highways Department
• Sewerage Undertaker

KEY

- Existing Foul Sewer
- Existing Storm Sewer
- Private Foul Drains
- Private Storm Drains
- Perforated pipe
- Adoptable Foul Sewers
- Foul to be installed using trenchless directional drilling below the RPA's.
- Adoptable Storm Sewers
- Highway Drainage
- Drainage Channel
- Gully
- Storm Rodding Eye
- Permeable Paving
- Gravel Margins
- Swale with perforated underdrain
- Existing Sewer Easement

CDM Note

These drawings have been produced with reference to the CDM Regulations 2015.
Please note that these are pre-construction phase drawings and should be subject to further design risk management as required in accordance with Regulation 9.

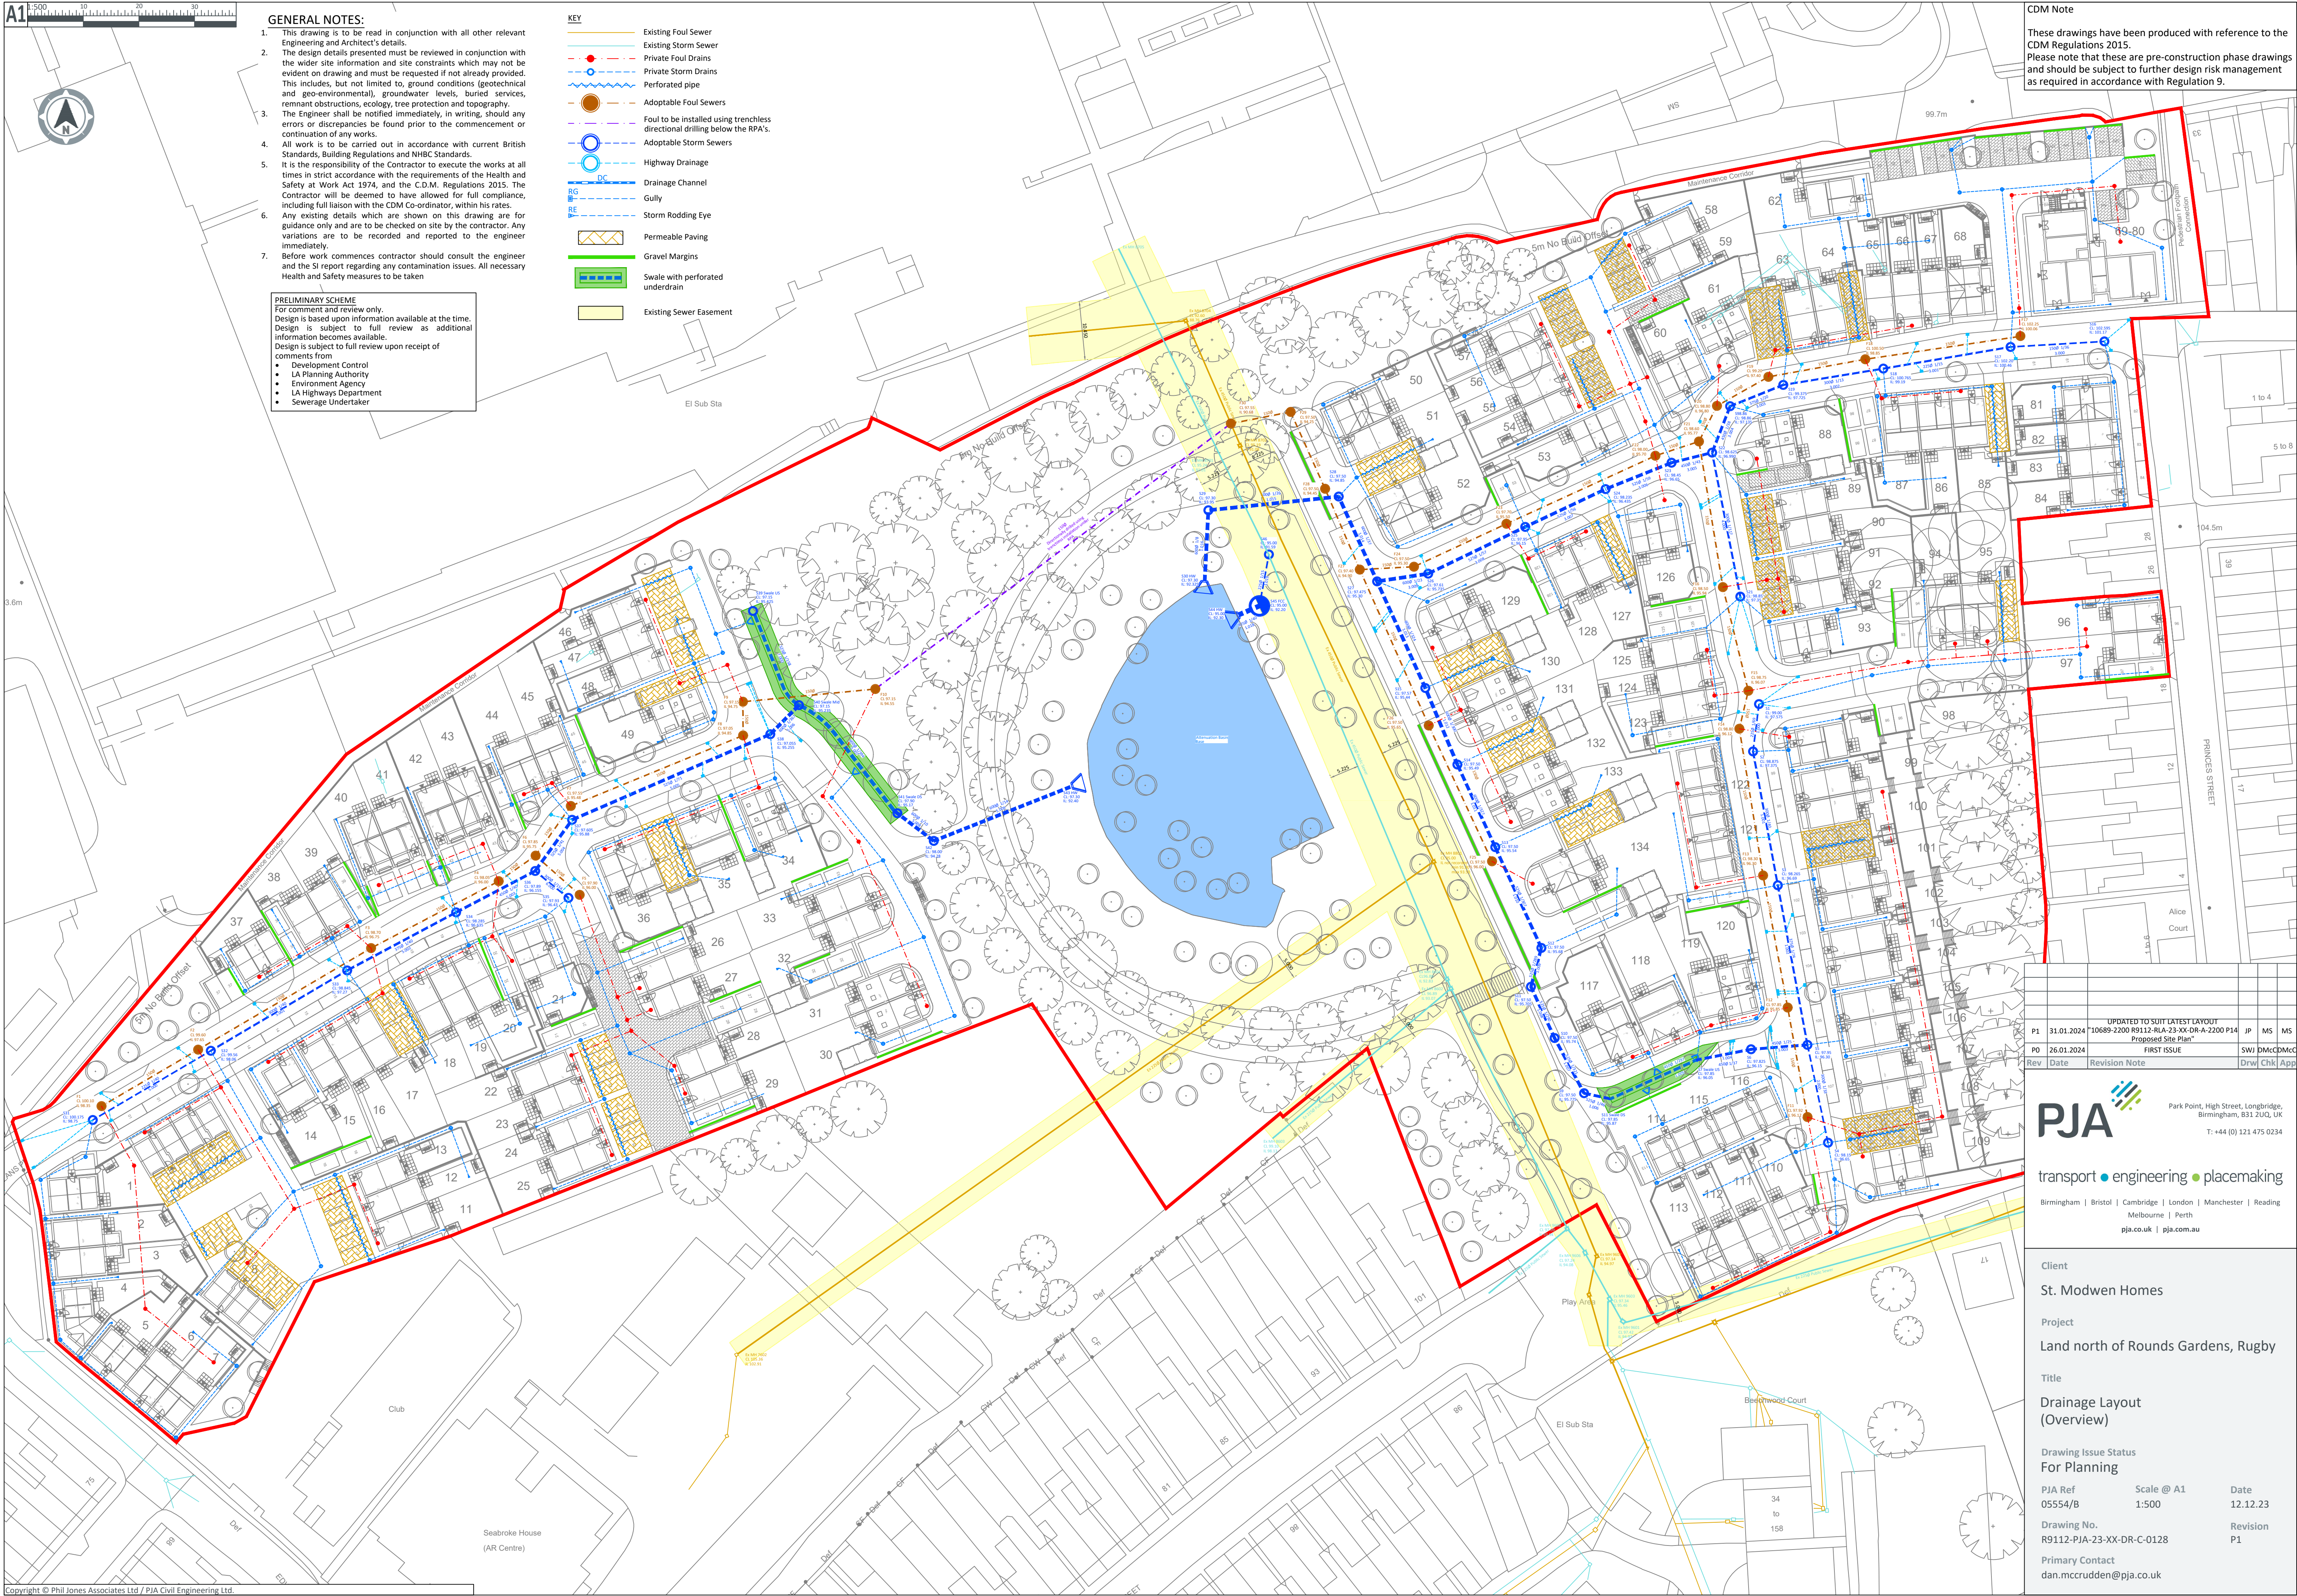

UPDATED TO SUIT LATEST LAYOUT					
P1	31.01.2024	10689-2200 R9112-RLA-23-XX-DR-A-2200 P14	JP	MS	MS
Proposed Site Plan					
P0	26.01.2024	FIRST ISSUE	SWJ	DMCDMcC	
Rev	Date	Revision Note	Drw	Chk	App

PJA
transport • engineering • placemaking
Birmingham | Bristol | Cambridge | London | Manchester | Reading
Melbourne | Perth
pja.co.uk | pja.com.au

Park Point, High Street, Longbridge,
Birmingham, B31 2UQ, UK
T: +44 (0) 121 475 0234

Client
St. Modwen Homes

Project
Land north of Rounds Gardens, Rugby

Title
Drainage Layout (Overview)

Drawing Issue Status
For Planning

PJA Ref
05554/B

Scale @ A1
1:500

Date
12.12.23

Drawing No.
R9112-PJA-23-XX-DR-C-0128

Revision
P1

Primary Contact
dan.mccruden@pja.co.uk